

Stellar Patrol of the Third Galactic Union

OFFICIAL BLUEPRINTS



The blueprints herein are printed and disbursed solely for the uses and purposes of the Stellar Patrol of the Third Galactic Union as outlined in the Stellar Patrol Blueprint Rules and Regulations Handbook or as determined by an authorized disburser of these blueprints or by any commanding officer provided that such uses or purposes are in a manner consistent with the rules and regulations of the Stellar Patrol. Failure to comply with said rules and regulations with regard to the confidentiality of Stellar Patrol blueprints will be treated as an act of treason and punishment determined accordingly. All local restrictions apply.



Elevator



Bed, standard Patrol issue



Toilet stall



Utility shaft and air duct



Desk and Chair, personal



Access hatch



(Non-closing) Doorway



Chair, reading



Auto-door



Shrubs



Security auto-door



Table and Chairs



Air vent, horizontal



Tub, bathing

FPU

Food Preparation Unit



Shower stall

FDU

Food Dispensing Unit



Toilet



Wardrobe, personal



Sink, SanFac-type

NOTE: Compass directions are relative to standard Galactic North. "UP" and "DOWN" are relative to the Station's internal artificial gravity.

DEEP SPACE STATION
GAMMA-DELTA-GAMMA CLASS

Stellar Patrol Corps
of Engineers

Drawn by:
Cmdr. Trip Flagstone

Scale —

Date: 1133713.20

KEY

G-IS6-1BLUE

NOTE (I): Only connecting tubes to official Stellar Patrol Deep Space Station Sub-Modules may be attached to Command Module at these points.

GALACTIC NORTH



SCIENTIFIC SUB-MODULE
(optional)

See Note (I)

Dome

See Note (I)

MILITARY SUB-MODULE
(optional)

Docking Bays

See Note (I)

DIPLOMATIC SUB-MODULE
(optional)

COMMAND MODULE

Diameter	36m
Volume	24,429m ³
Usable floor area	6,823m ²

Normal complement

Station Commander	1
Officers	6
Crew	36
Total Personnel	43

G-IS6-2BLUE

DEEP SPACE STATION GAMMA-DELTA-GAMMA CLASS

Stellar Patrol Corps
of Engineers

Drawn by:
Lt. Cmdr. Milo Sputter

STATION EXTERIOR — OVERVIEW

Scale 1:750

Date: 11337.5.1

1 OF 9

LEVEL ONE: Garden and Observatory Dome

LEVEL THREE: Gym, Theatre, Chapel, Laundry

LEVEL FIVE: Command Center, Sick Bay, PX, Brig, Robot Shop, File Room, Workshop, access to Bay #2, Sub-Module connections.

LEVEL SEVEN: Printing Plant, Paper Recycling Plant

LEVEL NINE: Main Computer, Computer Control, Water Tanks



LEVEL TWO: Mess Hall, Library, Meeting Rooms, Main Storage

LEVEL FOUR: Male Barracks, Female Barracks, SanFac, access to Bay #3

LEVEL SIX: Officers' Quarters, Auxiliary Barracks, access to Bays #1 and #4, Armory, Shipping Room

LEVEL EIGHT: Power Plant, Oxygen Generation, Water Purification, Arti-Grav

Bay 3

Bay 2



Bay 1

Bay 4


Cooling Fins

DEEP SPACE STATION GAMMA-DELTA-GAMMA CLASS		
Stellar Patrol Corps of Engineers		Drawn by: Lt. Cmdr. Milo Sputter
COMMAND MODULE INTERIOR—SIDE VIEW CUTAWAY		
Scale 1:375	Date: 113375.2	2 OF 9

G-IS6-3BLUE

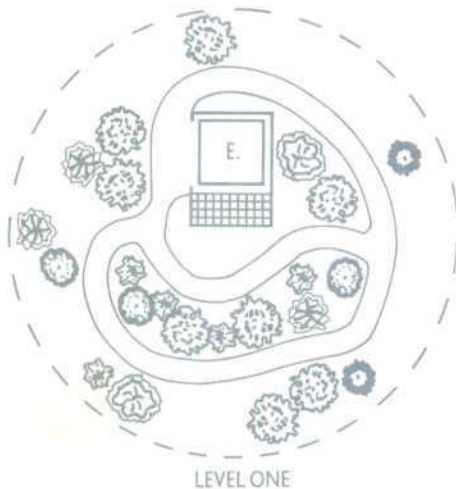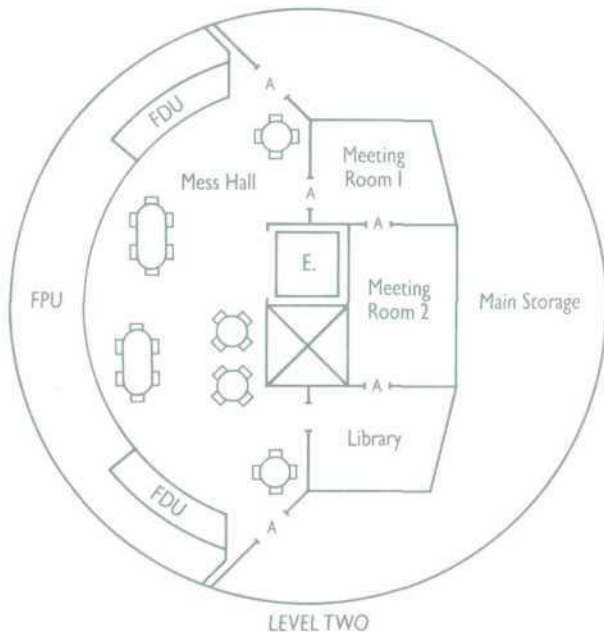

DEEP SPACE STATION GAMMA-DELTA-GAMMA CLASS		
Stellar Patrol Corps of Engineers		Drawn by: Lt. Cmdr. Milo Sputter
COMMAND MODULE—LEVEL ONE & LEVEL TWO PLAN		
Scale 1:375	Date: 113375.5	3 OF 9

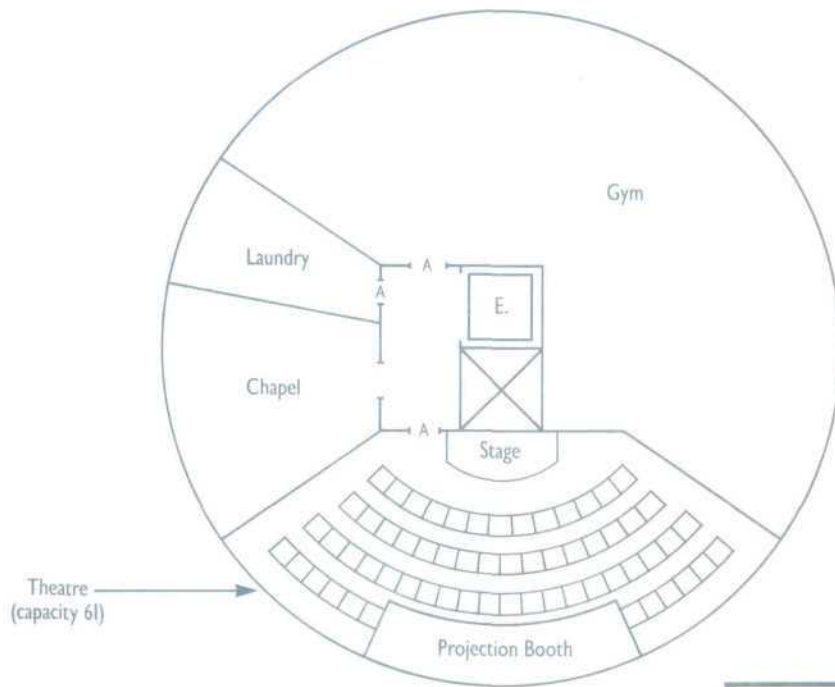

DEEP SPACE STATION
GAMMA-DELTA-GAMMA CLASS

Stellar Patrol Corps
of Engineers

Drawn by:
Lt. Cmdr. Milo Spatter


COMMAND MODULE LEVEL THREE PLAN

Scale 1:375


Date: 113375.12

4 OF 9

G-1S6-5BLUE

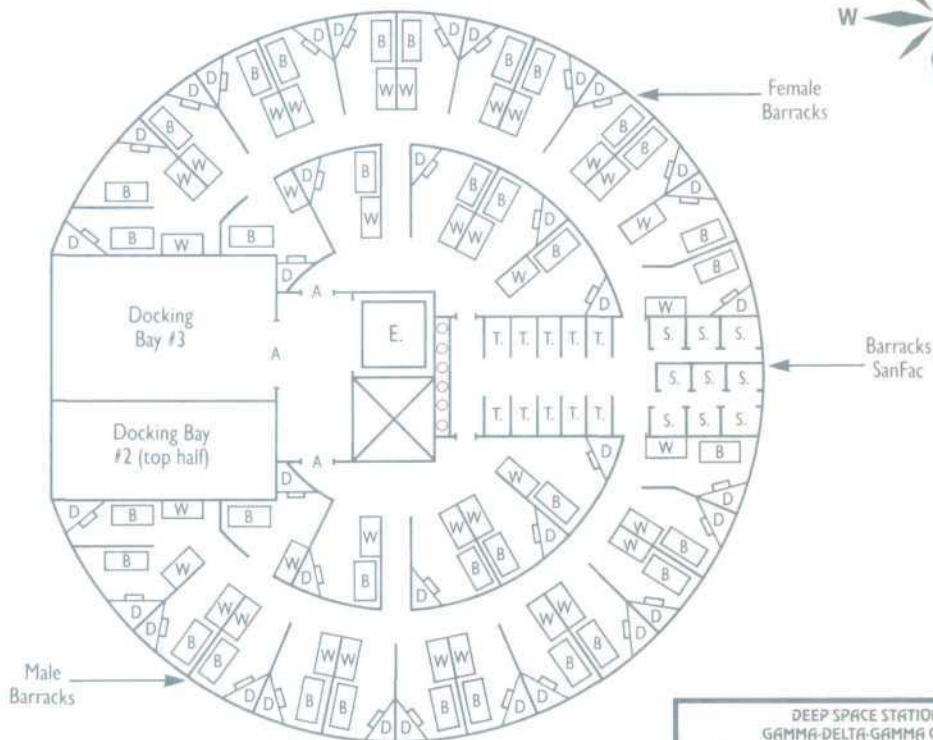

5 OF 9

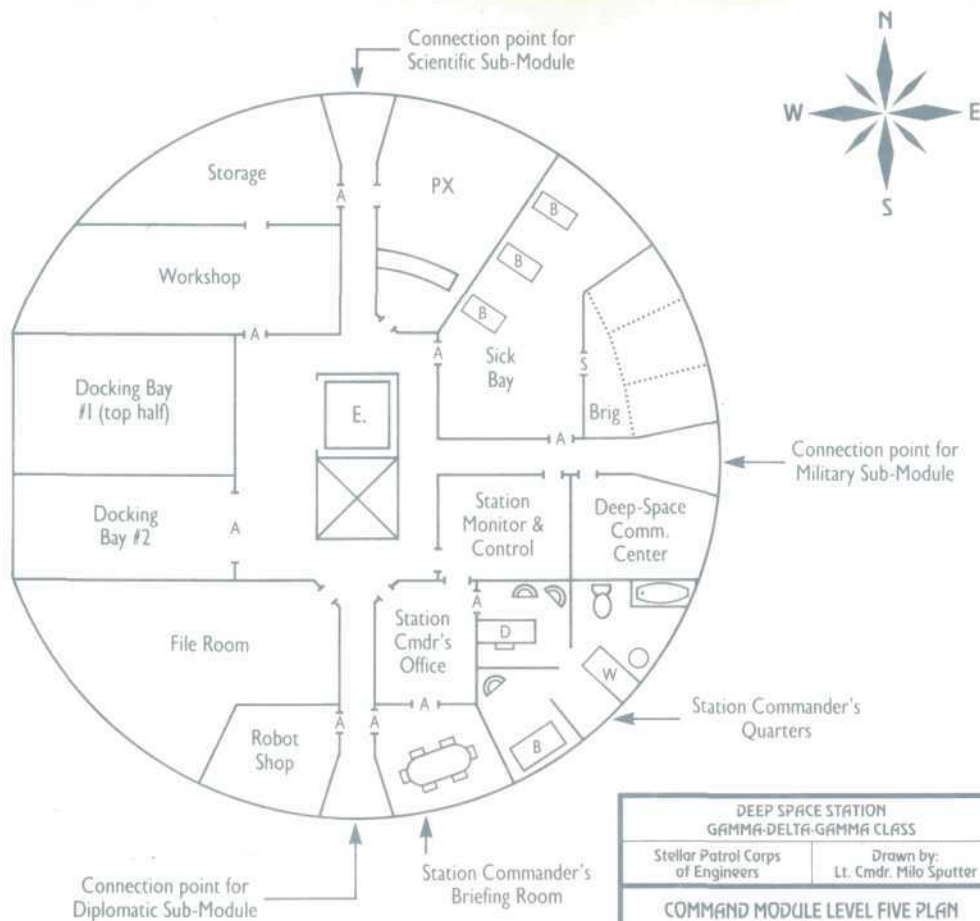

DEEP SPACE STATION
GAMMA-DELTA-GAMMA CLASS

Stellar Patrol Corps
of Engineers

Drawn by:
Lt. Cmdr. Milo Sputter

COMMAND MODULE LEVEL FIVE PLAN

Scale 1:375


Date: 11337.8.18

6 OF 9

G-IS6-7BLUE



Auxiliary Barracks

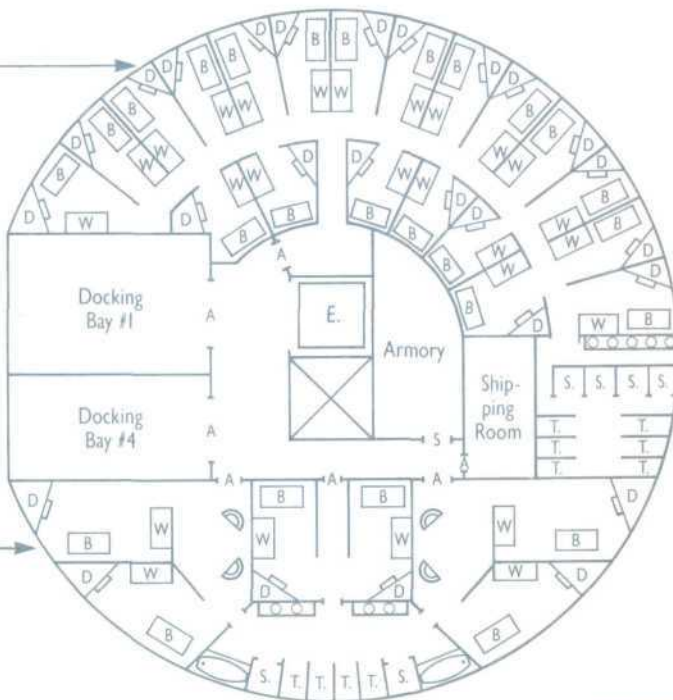

Officers' Quarters
A, B, and C

Officers' SanFac

Auxiliary SanFac

DEEP SPACE STATION
GAMMA-DELTA-GAMMA CLASS

Stellar Patrol Corps
of Engineers

Drawn by:
Lt. Cmdr. Milo Sputter


COMMAND MODULE LEVEL SIX PLAN

G-IS6-8BLUE

Scale 1:375

Date: 11337.13.10

7 OF 9

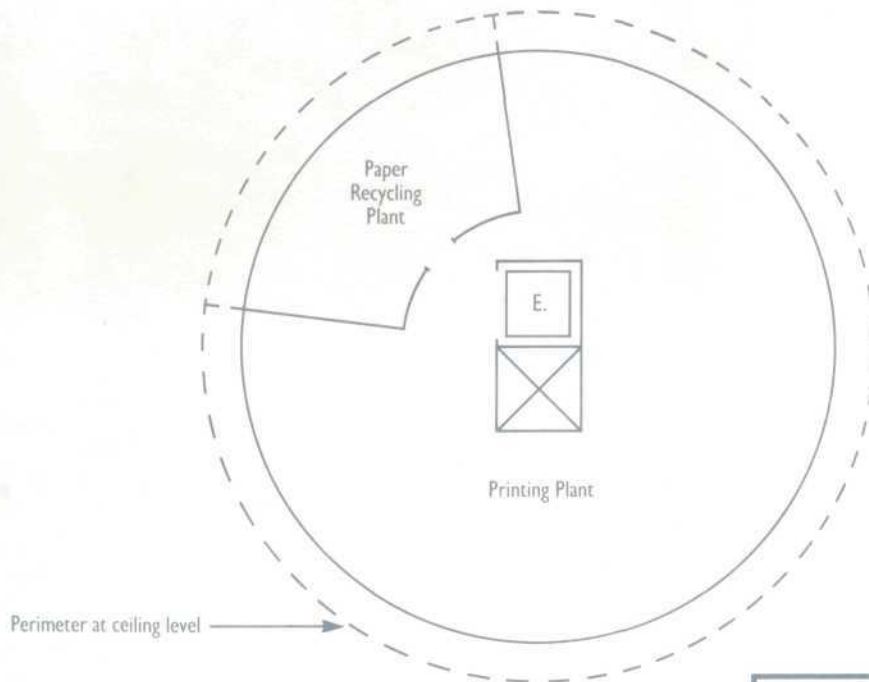

DEEP SPACE STATION
GAMMA-DELTA-GAMMA CLASS

Stellar Patrol Corps
of Engineers

Drawn by:
Cmdr. Trip Flogstone



COMMAND MODULE LEVEL SEVEN PLAN

G-IS6-9BLUE

Scale 1:375

Date: 1133713.20

8 OF 9

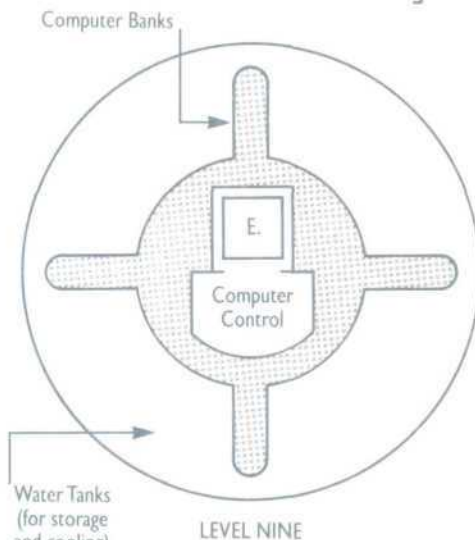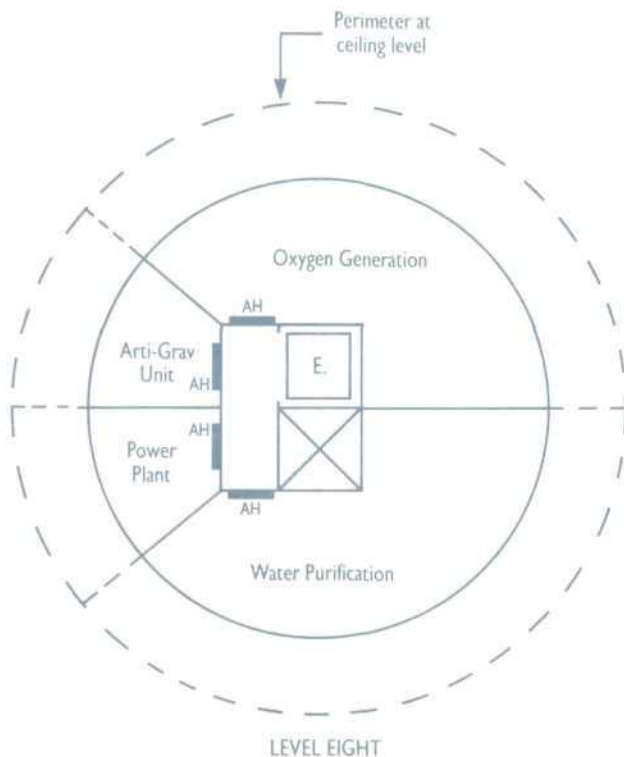

Water Tanks
(for storage
and cooling)

DEEP SPACE STATION GAMMA-DELTA-GAMMA CLASS		
Stellar Patrol Corps of Engineers		Drawn by: Cmdr. Trip Flagstone
COMMAND MODULE LEVEL EIGHT & NINE PLAN		
Scale 1:375	Date: 11337.13.20	9 OF 9